



**CBA BUILDING THIRD FLOOR KEY PLAN**

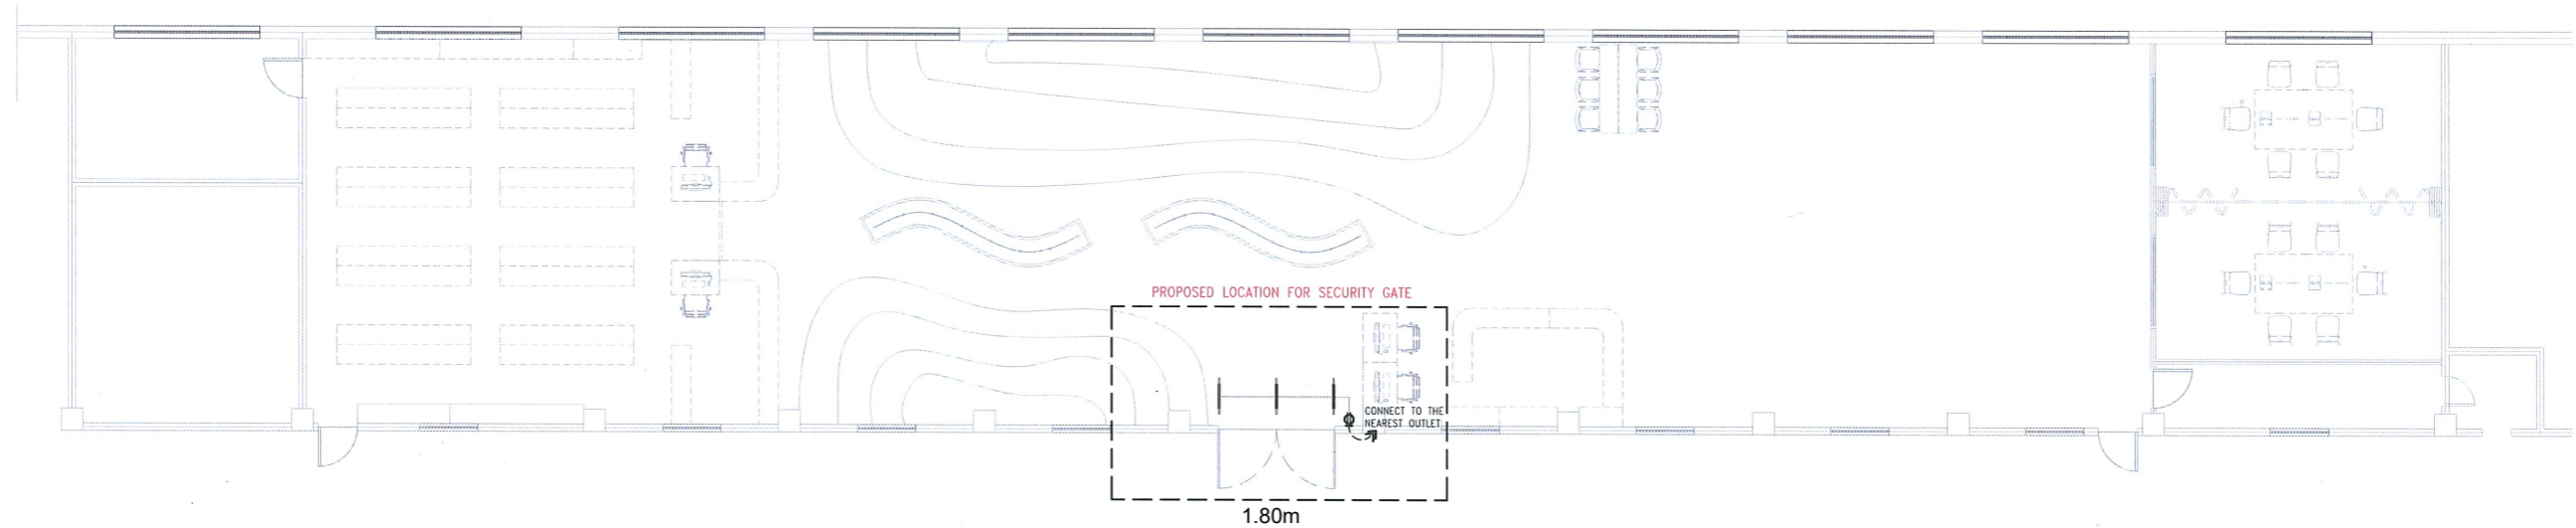

**TSU MAIN LIBRARY FLOOR PLAN**

SCALE 1:150 MTS.

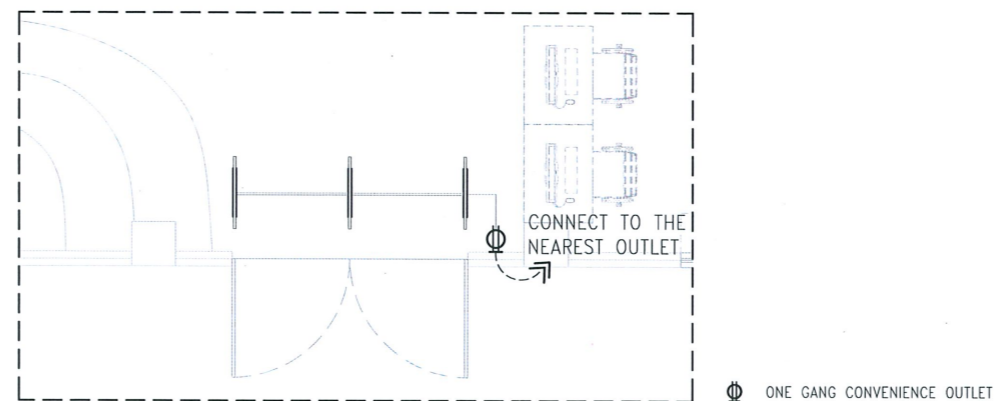


**POWER LAYOUT**




**TARLAC STATE UNIVERSITY**  
Facilities Development and Management Office  
Romulo Boulevard, Tarlac City, Philippines 2300

PROJECT TITLE: INSTALLATION OF SECURITY GATE	PREPARED BY: AR. MARK ANTHONY L. PUNZALAN ARCHITECT	CHECKED BY: AR. ARLEN M. GUIEB PLANNING UNIT HEAD, FDMO	CERTIFIED BY: AR. CHERRY L. FABIANES DIRECTOR, FDMO	REQUESTING OFFICE: MS. CYNTHIA M. BOGNOT LIBRARY DIRECTOR	SHEET CONTENTS: AS SHOWN	SHEET NO.:
PROJECT LOCATION: TARLAC STATE UNIVERSITY, MAIN, SAN ISIDRO AND LUCINDA CAMPUS					DATE:	PAGE NO.:

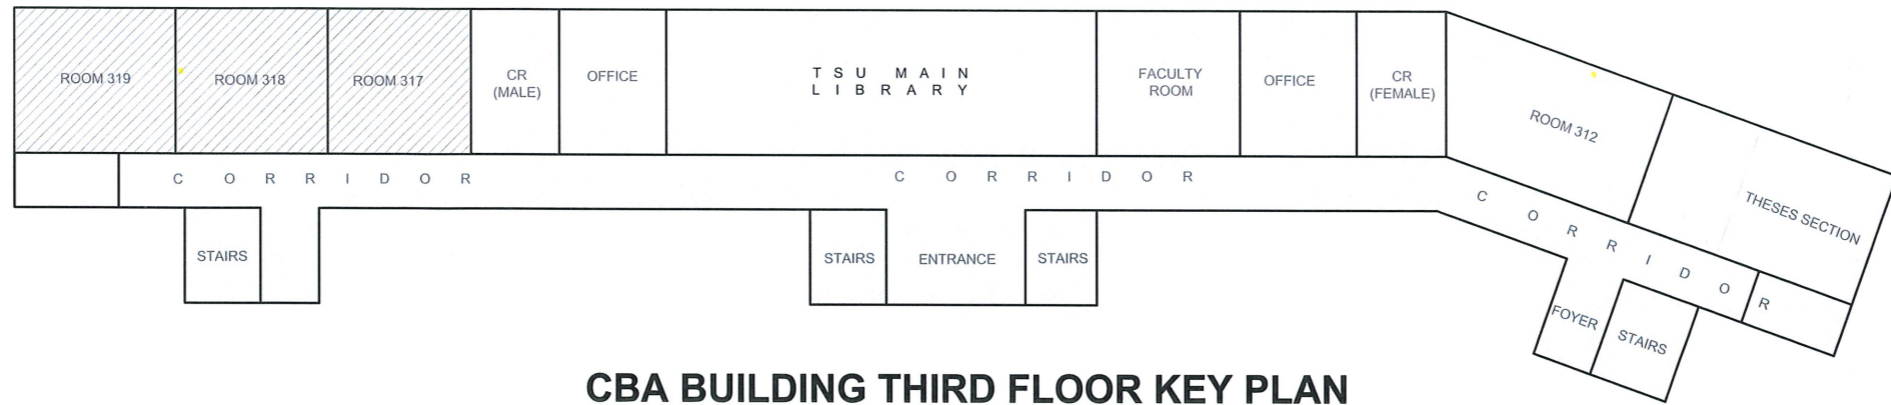


**CBA BUILDING THIRD FLOOR KEY PLAN**

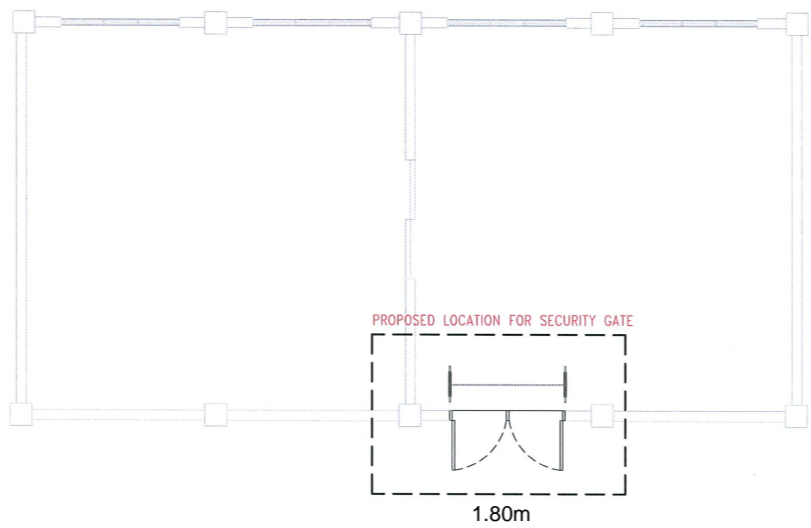

**TSU LIBRARY THESESE SECTION FLOOR PLAN**

SCALE 1:150 MTS.

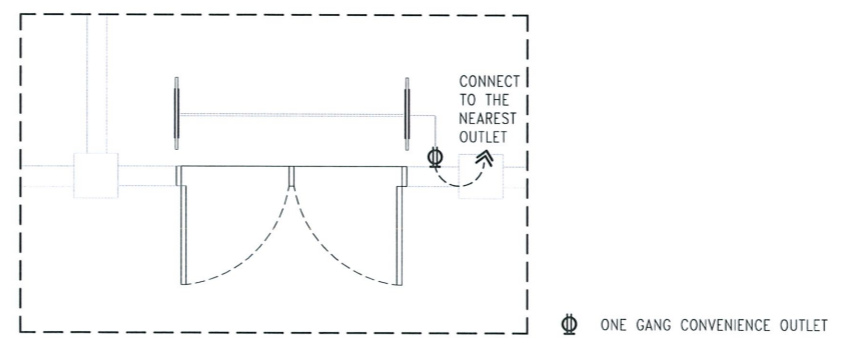

**POWER LAYOUT**



PROJECT TITLE:  
INSTALLATION OF SECURITY GATE

PROJECT LOCATION:  
TARLAC STATE UNIVERSITY, MAIN, SAN ISIDRO AND LUCINDA CAMPUS

PREPARED BY:  
AR. MARK ANTHONY L. PUNZALAN  
ARCHITECT

ENGR. MARK JOMELLE Q. NATIVIDAD  
ELECTRICAL ENGINEER, FDMO

CHECKED BY:  
AR. ARLEN M. GUIEB  
PLANNING UNIT HEAD, FDMO




CERTIFIED BY:  
AR. CHERRY L. FABIANES  
DIRECTOR, FDMO

REQUESTING OFFICE:  
MS. CYNTHIA M. BOGNOT  
LIBRARY DIRECTOR


SHEET CONTENTS:  
AS SHOWN

PAGE NO:  
DATE:





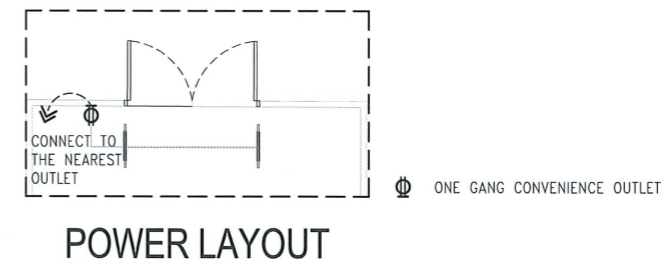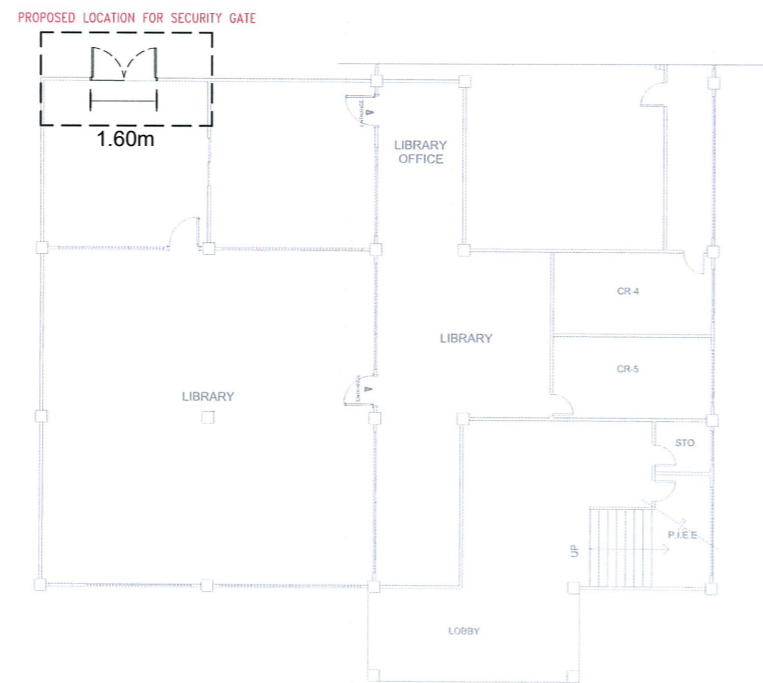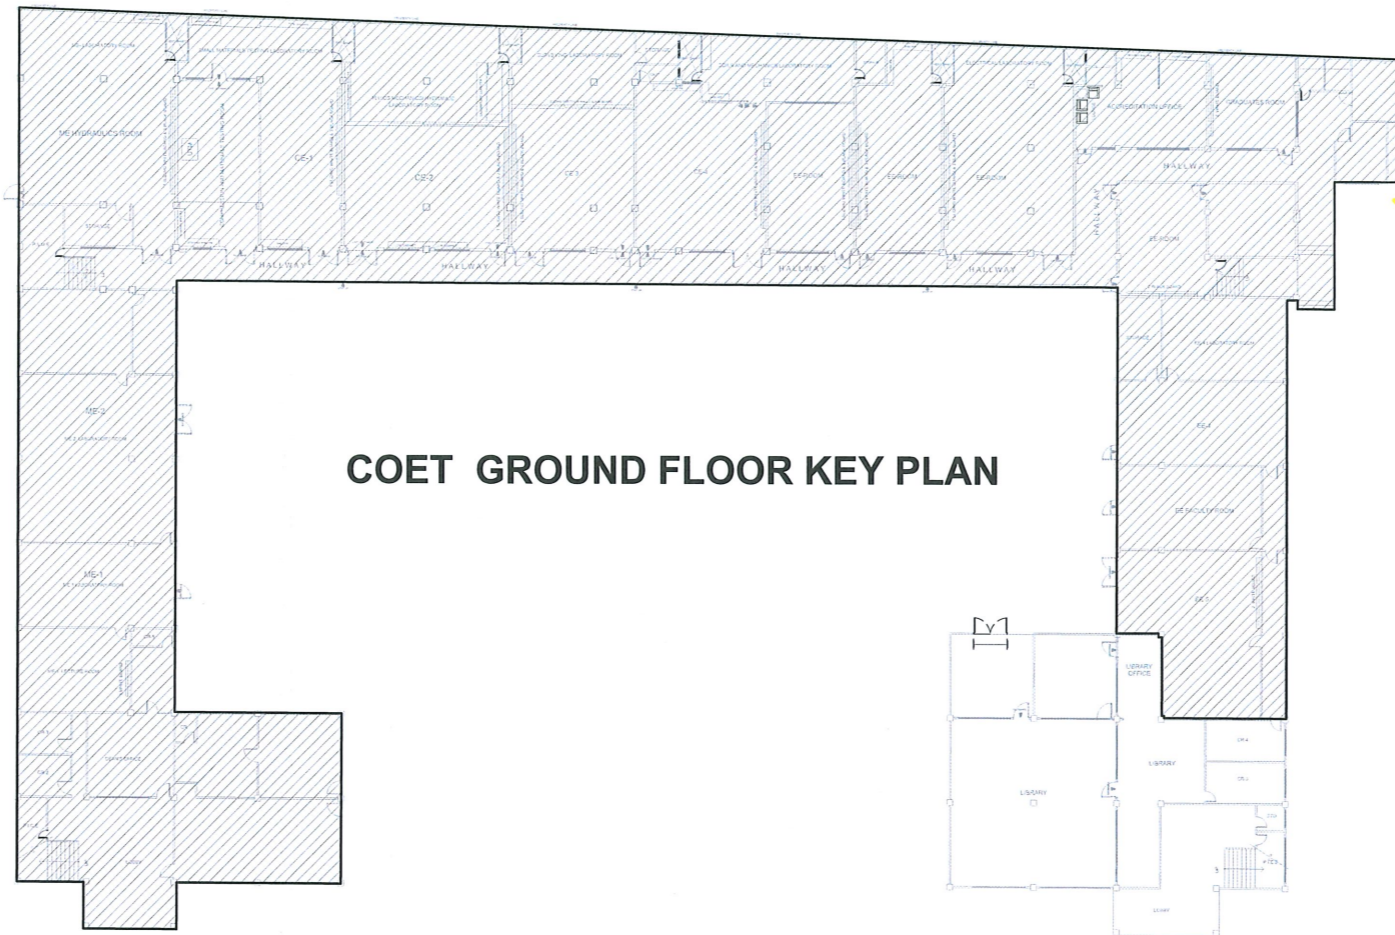

PROJECT TITLE: INSTALLATION OF SECURITY GATE	PREPARED BY: AR. MARK ANTHONY L. RUNZALAN ARCHITECT	CHECKED BY: ENGR. MARK JOMELLE O. NATIVIDAD ELECTRICAL ENGINEER, FDMO	CERTIFIED BY: AR. ARLEN M. GUIEB PLANNING UNIT HEAD, FDMO	REQUESTING OFFICE: AR. CHERRY L. FABIANES DIRECTOR, FDMO	MS. CYNTHIA M. BOGNOT LIBRARY DIRECTOR	SHEET CONTENTS: AS SHOWN	SHEET NO.:
PROJECT LOCATION: TARLAC STATE UNIVERSITY, MAIN, SAN ISIDRO AND LUCINDA CAMPUS						DATE:	PAGE NO.:

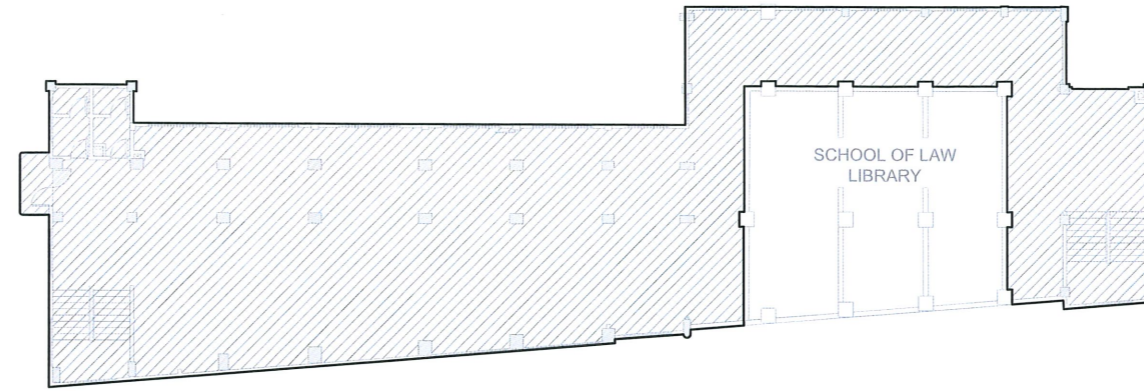

**SCHOOL OF LAW SECOND FLOOR KEY PLAN**

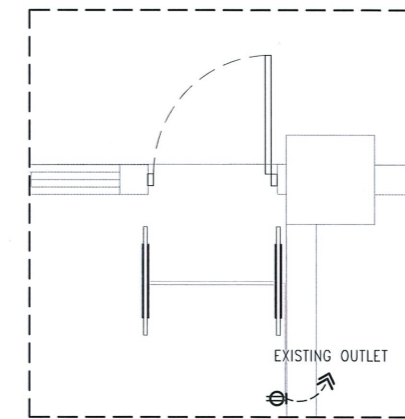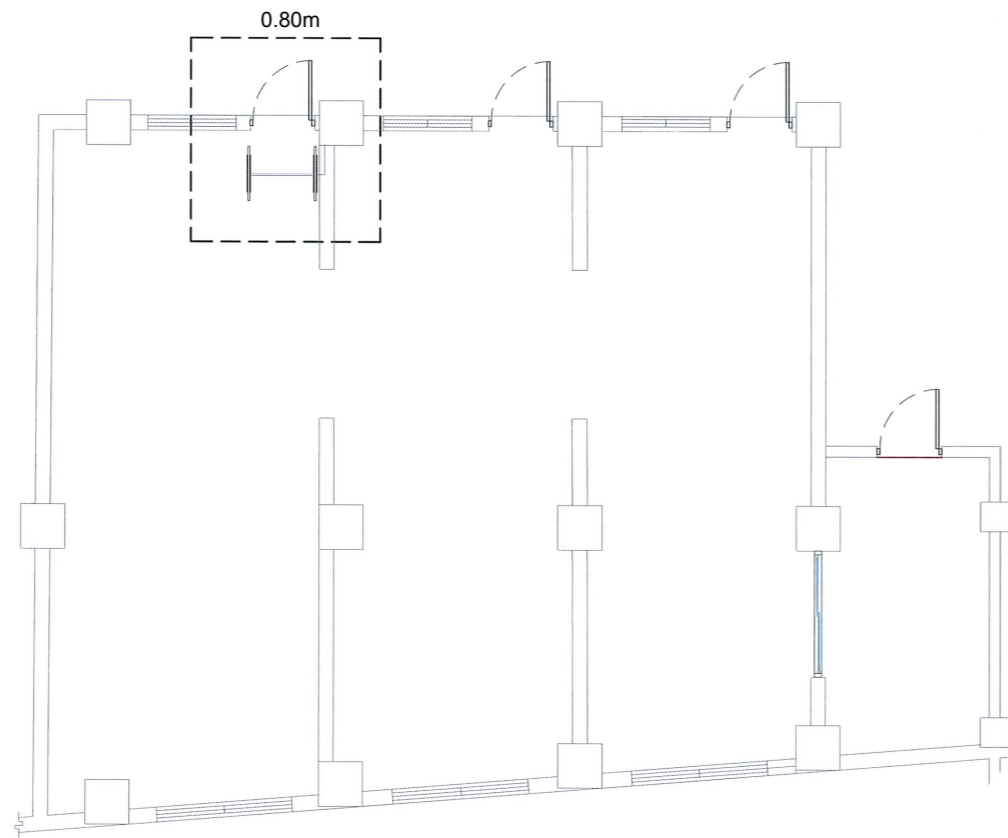

**POWER LAYOUT**

EXISTING OUTLET AT THE SCHOOL OF LAW LIBRARY




**SCHOOL OF LAW LIBRARY FLOOR PLAN**

SCALE 1:100 MTS.



<b>TARLAC STATE UNIVERSITY</b> Facilities Development and Management Office Romulo Boulevard, Tarlac City, Philippines 2300	PROJECT TITLE:	PREPARED BY:	CHECKED BY:	CERTIFIED BY:	REQUESTING OFFICE:	SHEET CONTENTS:	SHEET NO.:
	INSTALLATION OF SECURITY GATE PROJECT LOCATION: TARLAC STATE UNIVERSITY, MAIN, SAN ISIDRO AND LUCINDA CAMPUS	AR. MARK ANTHONY L. PUNZALAN ARCHITECT ENGR. MARK JOMELLE Q. NATIVIDAD ELECTRICAL ENGINEER, FDMO	AR. ARLEN M. GUIEB PLANNING UNIT HEAD, FDMO	AR. CHERRY L. FABIANES DIRECTOR, FDMO	MS. CYNTHIA M. BOGNOT LIBRARY DIRECTOR	AS SHOWN	PAGE NO.:
						DATE:	



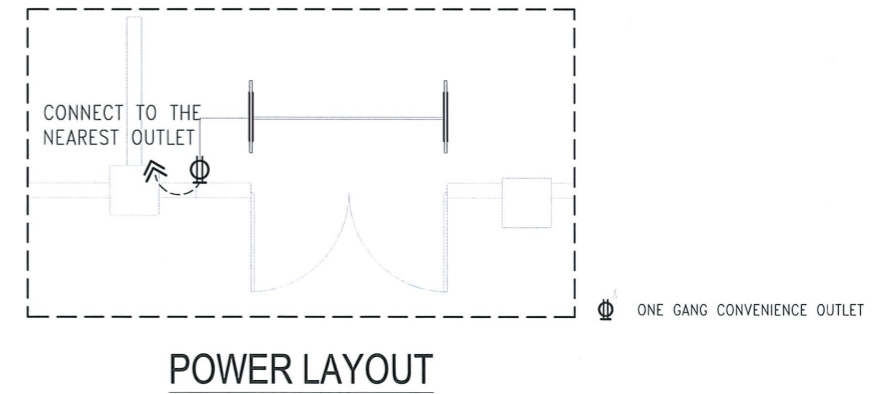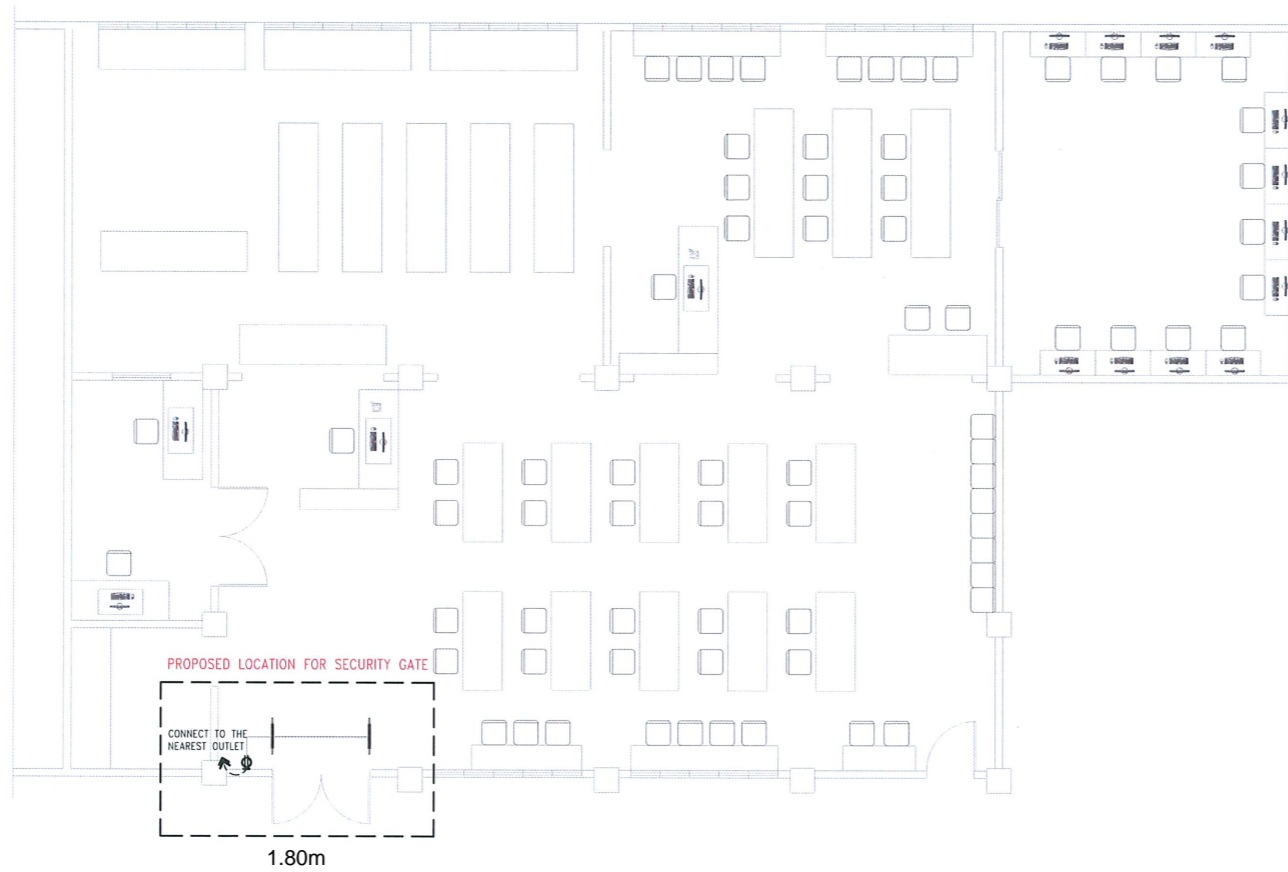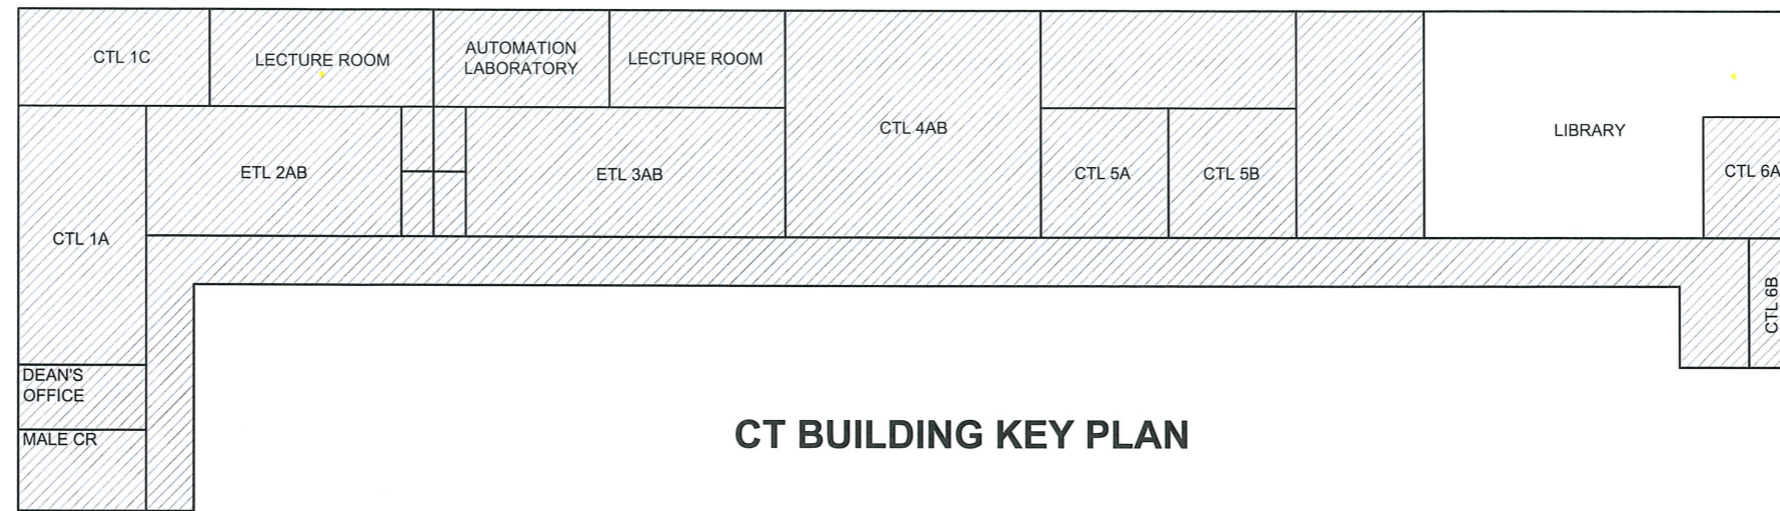

PROJECT TITLE:  
INSTALLATION OF SECURITY GATE

PROJECT LOCATION:  
TARLAC STATE UNIVERSITY, MAIN, SAN ISIDRO AND LUCINDA CAMPUS

PREPARED BY:  
AR. MARK ANTHONY L. PUNZALAN  
ARCHITECT

ENGR. MARK JOMELLE O. NATIVIDAD  
ELECTRICAL ENGINEER, FDMO

CHECKED BY:  
AR. ARLEN M. GUIEB  
PLANNING UNIT HEAD, FDMO



CERTIFIED BY:  
AR. CHERRY L. FABIANES  
DIRECTOR, FDMO

REQUESTING OFFICE:  
MS. CYNTHIA M. BOGNOT  
LIBRARY DIRECTOR

SHEET CONTENTS:  
AS SHOWN


SHEET NO.:  
PAGE NO.:  
DATE:



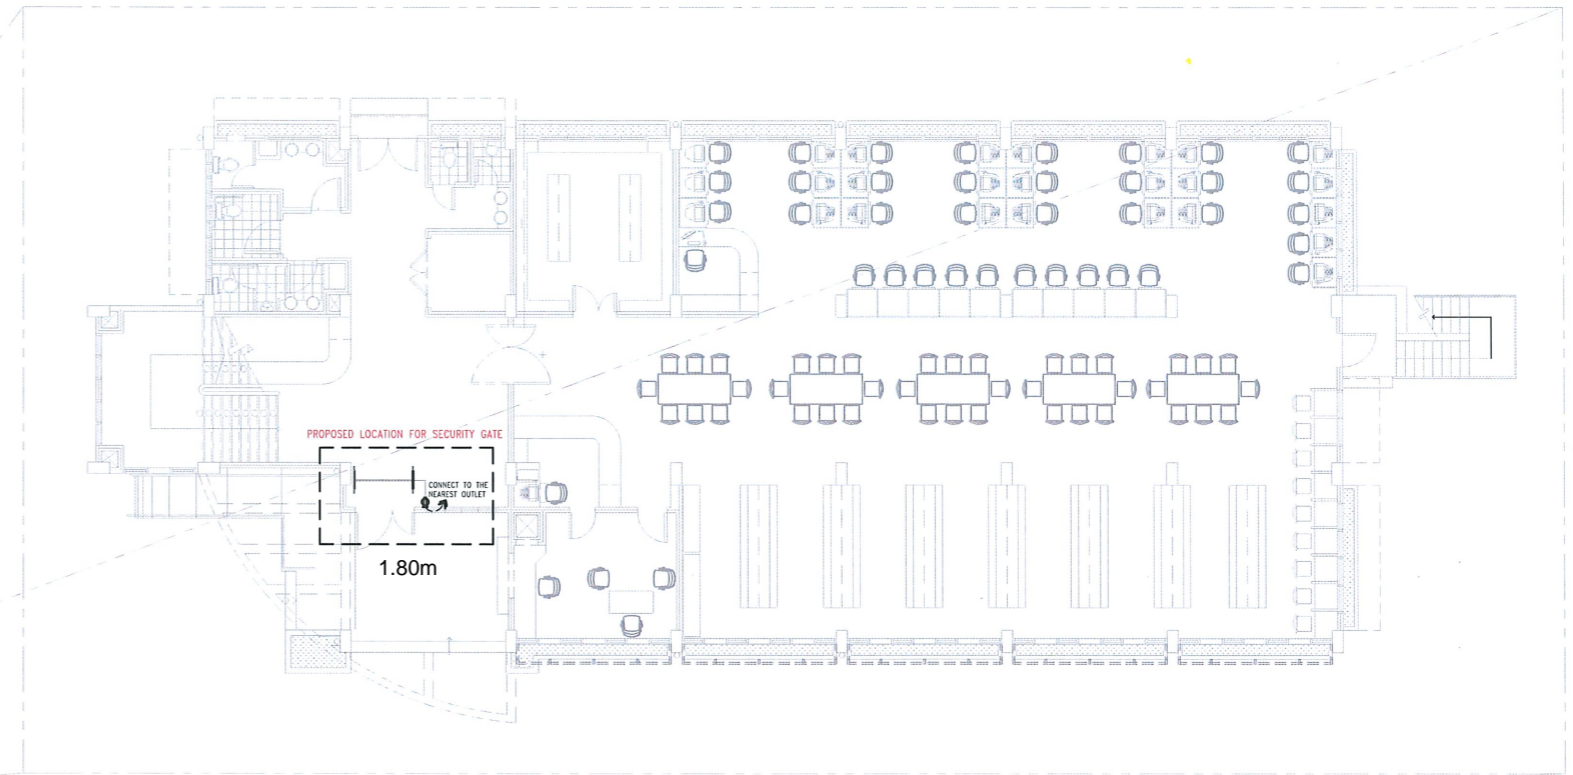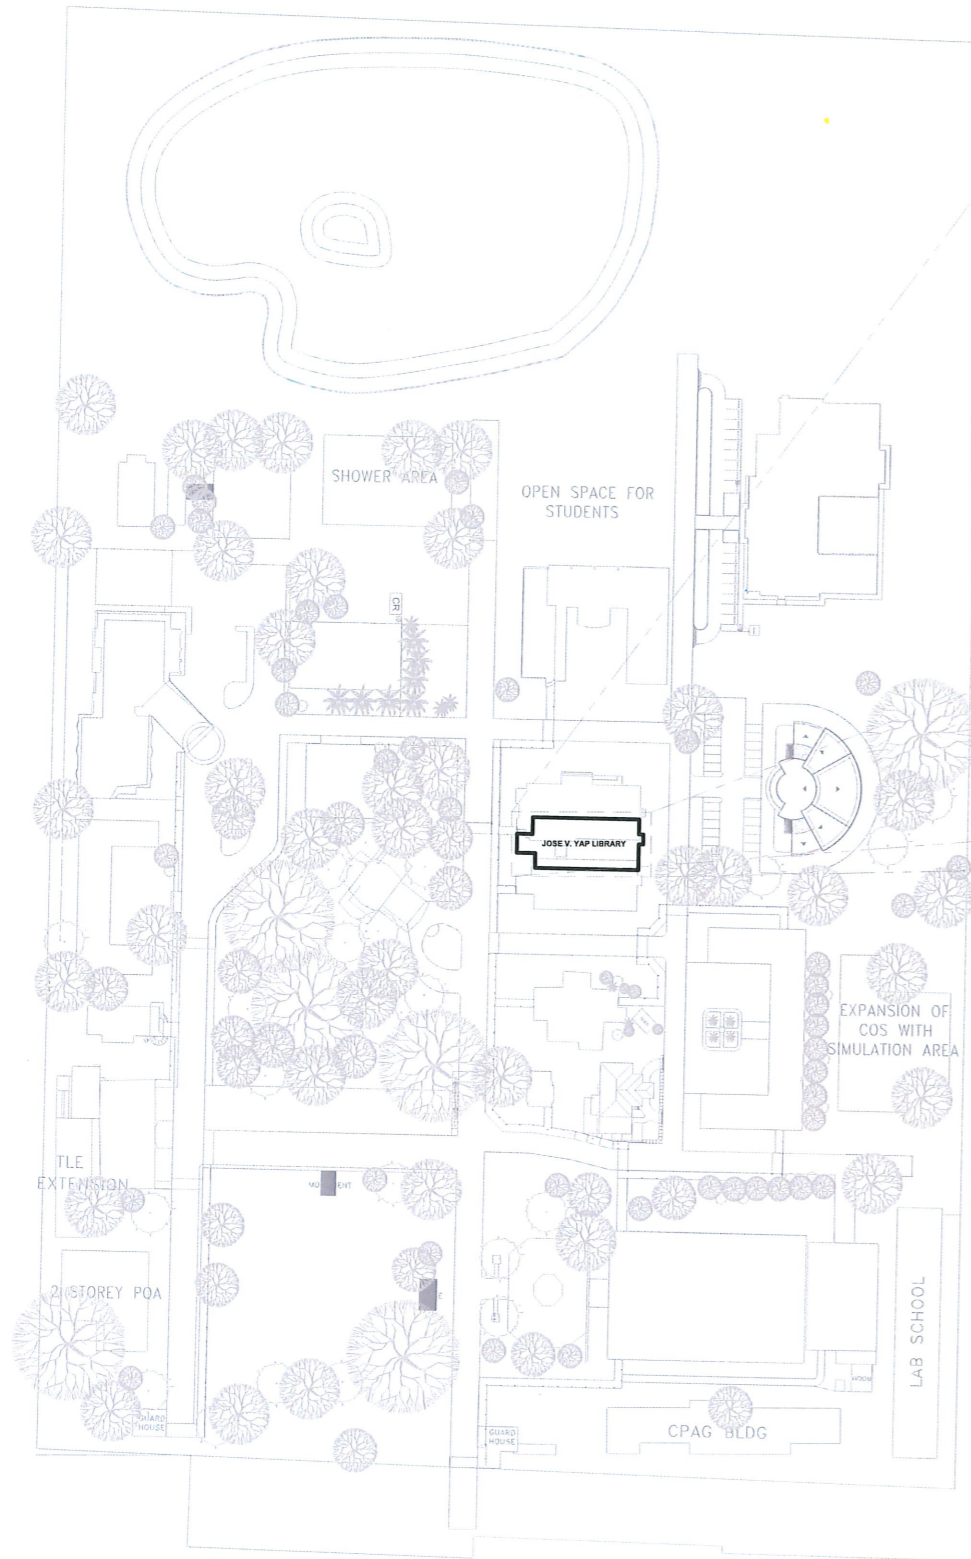

## JOSE V. YAP LIBRARY FLOOR PLAN

SCALE 1:200 MTS.

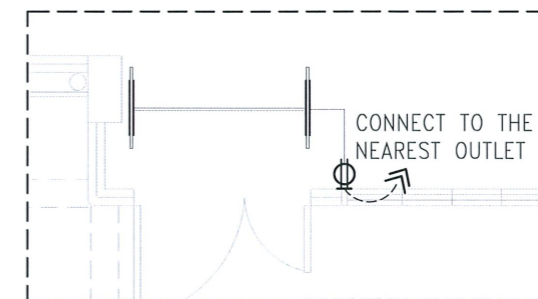

☉ ONE GANG CONVENIENCE OUTLET

## POWER LAYOUT


## LUCINDA CAMPUS SITE DEVELOPMENT PLAN




**TARLAC STATE UNIVERSITY**  
Facilities Development and  
Management Office  
Romulo Boulevard, Tarlac City, Philippines 2300

PROJECT TITLE: <b>INSTALLATION OF SECURITY GATE</b>	PREPARED BY: <i>[Signature]</i> AR. MARK ANTHONY L. PUNZALAN ARCHITECT	CHECKED BY: <i>[Signature]</i> ENGR. MARK JOMELLE O. NATIVIDAD ELECTRICAL ENGINEER, FDMO	CERTIFIED BY: <i>[Signature]</i> AR. ARLEN M. GUIEB PLANNING UNIT HEAD, FDMO	REQUESTING OFFICE: <i>[Signature]</i> AR. CHERRY L. FABIANES DIRECTOR, FDMO	MS. CYNTHIA M. BOGNOT LIBRARY DIRECTOR	SHEET CONTENTS: AS SHOWN	SHEET NO.:
PROJECT LOCATION: TARLAC STATE UNIVERSITY, MAIN, SAN ISIDRO AND LUCINDA CAMPUS						DATE:	PAGE NO.:



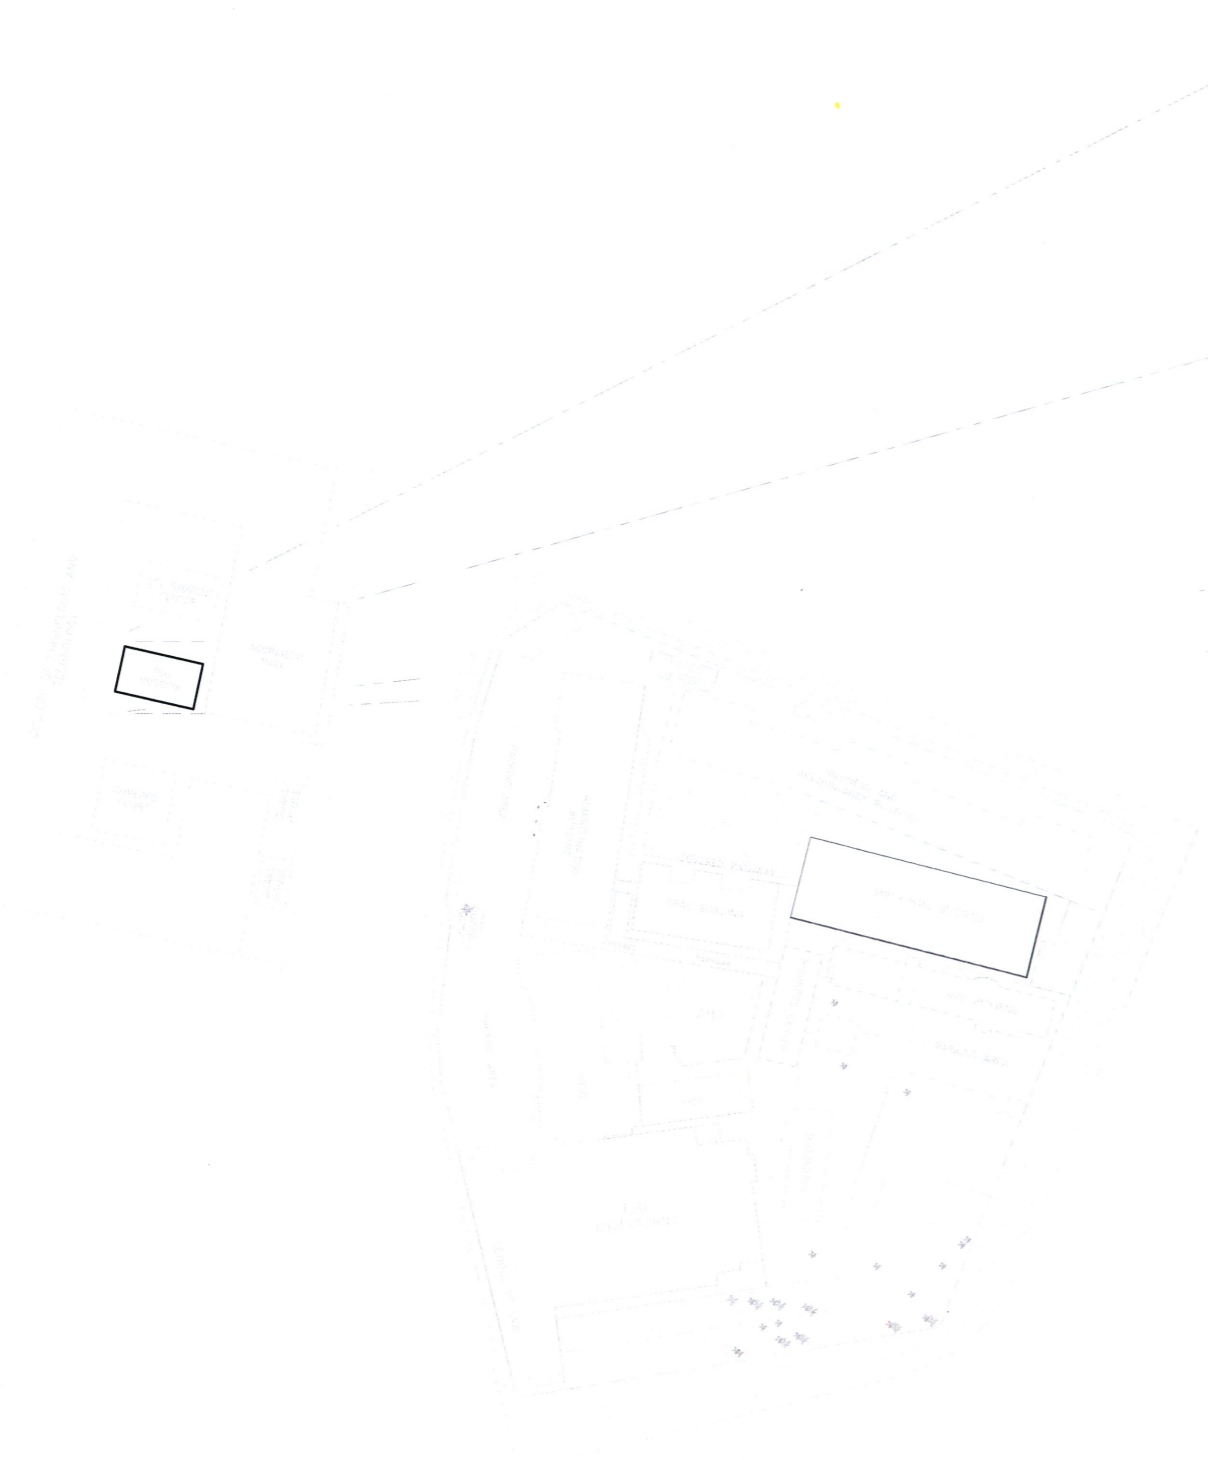


**MAIN CAMPUS SITE DEVELOPMENT PLAN**

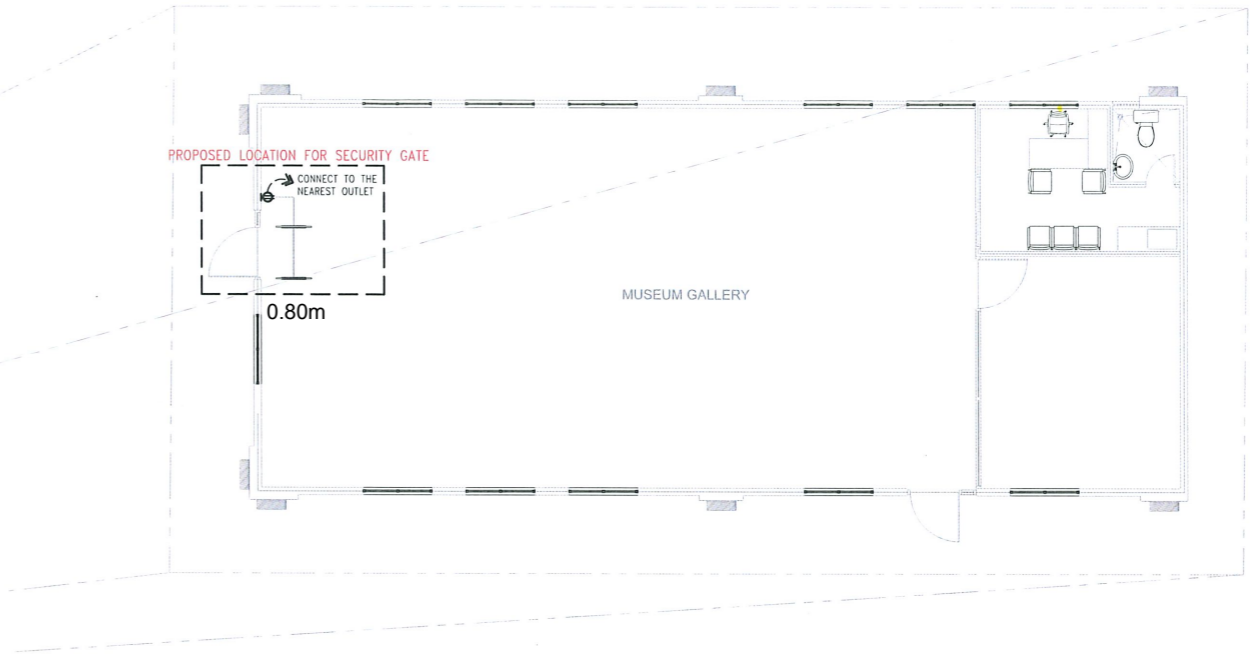

**TSU MUSEUM GALLERY FLOOR PLAN**

SCALE 1:150 MTS.

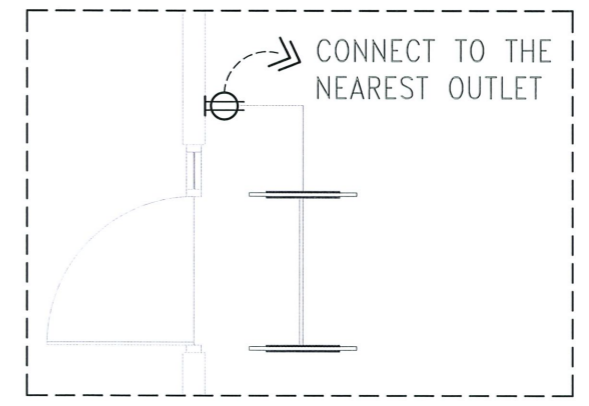

**POWER LAYOUT**



**TARLAC STATE UNIVERSITY**  
Facilities Development and Management Office  
Romulo Boulevard, Tarlac City, Philippines 2300

PROJECT TITLE:  
INSTALLATION OF SECURITY GATE

PROJECT LOCATION:  
TARLAC STATE UNIVERSITY, MAIN, SAN ISIDRO AND LUCINDA CAMPUS

PREPARED BY:  
AR. MARK ANTHONY L. PUNZALAN  
ARCHITECT

ENGR. MARK JOMELLE B. NATIVIDAD  
ELECTRICAL ENGINEER-FDMO

CHECKED BY:  
AR. ARLEN M. GUIEB  
PLANNING UNIT HEAD, FDMO

CERTIFIED BY:  
AR. CHERRY L. FABIANES  
DIRECTOR, FDMO

REQUESTING OFFICE:  
MS. CYNTHIA M. BOGNOT  
LIBRARY DIRECTOR

SHEET CONTENTS:  
AS SHOWN

SHEET NO.:  
PAGE NO.:  
DATE: